

PROPOSED WORKERS ACCOMODATION



 
DRAWING NO.	DESCRIPTION
1	COVER PAGE
2	AREA PLAN
3	SITE PLAN
4	FLOOR PLAN
5	ELEVATIONS 1
6	ELEVATIONS 2
7	SECTION & DETAILS
8	ELECTRICAL PLAN
9	SETOUT PLAN

REV	DESCRIPTION	DATE	DRW
1	INITIAL CONCEPT	19/01/2026	TL
2	UNIT ADJUSTMENTS	02/02/2026	TL

Owner : NEWTON ORCHARDS

Address: #22 STARKIES ROAD, MANJIMUP

Drawing Title: COVERPAGE



Fastlane
Design & Drafting

Mob: 0423 473 057
Email: fastlane.drafting@gmail.com

 
 
Date: 02/02/26 Scale: _____
Designed: TL
Checked: TL
Local Authority: Shire of Manjimup Sheet 1 Of 9
Plan/Diagram Number: .
CT Number: .
Revision: V2 ORIGINAL:A3



Owner : NEWTON ORCHARDS

Address: #22 STARKIES ROAD, MANJIMUP





Drawing Title: AREA PLAN



Fastlane
Design & Drafting

Mob: 0423 473 057
Email: fastlane.drafting@gmail.com


Date: 02/02/26 Scale: 1:5000
Designed: TL
Checked: TL
Local Authority: Shire of Manjimup Sheet 2 Of 9
Plan/Diagram Number: .
CT Number: .
Revision: V2 ORIGINAL:A3

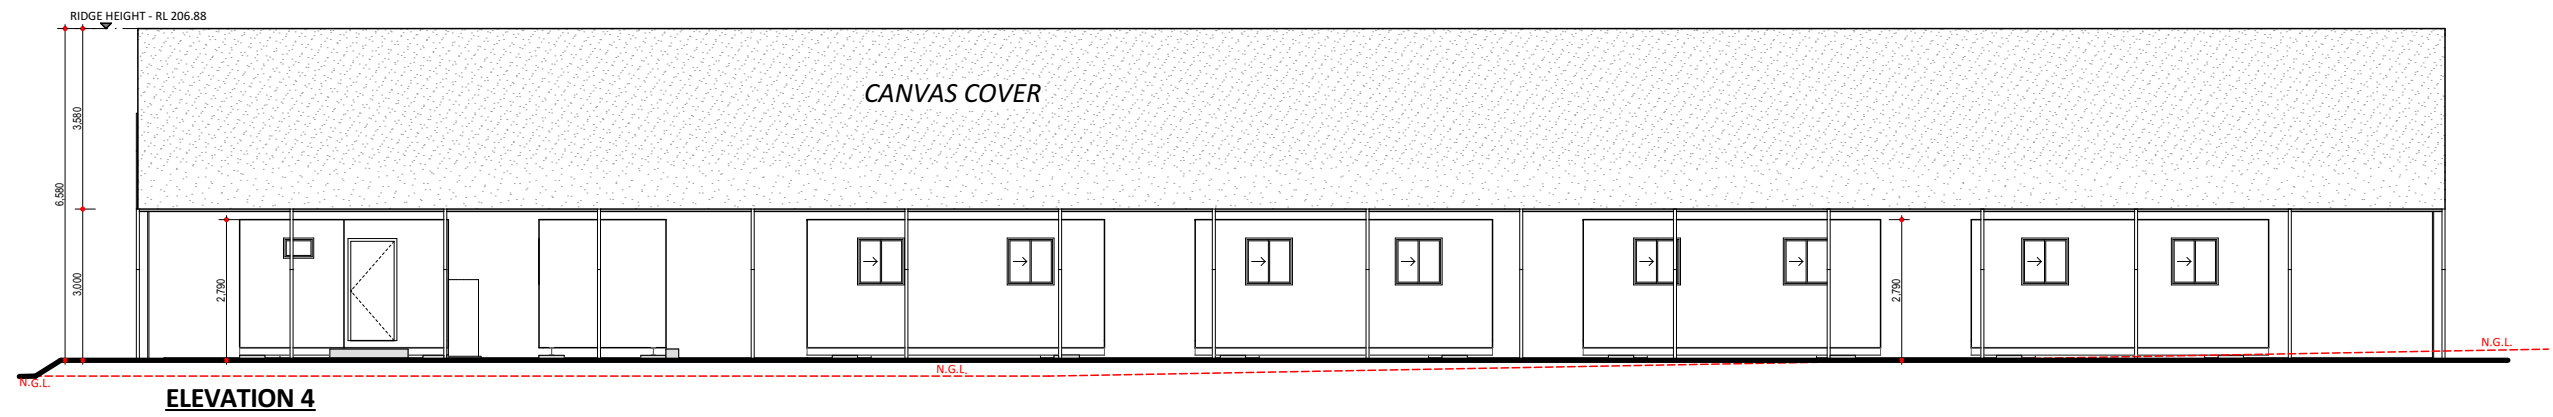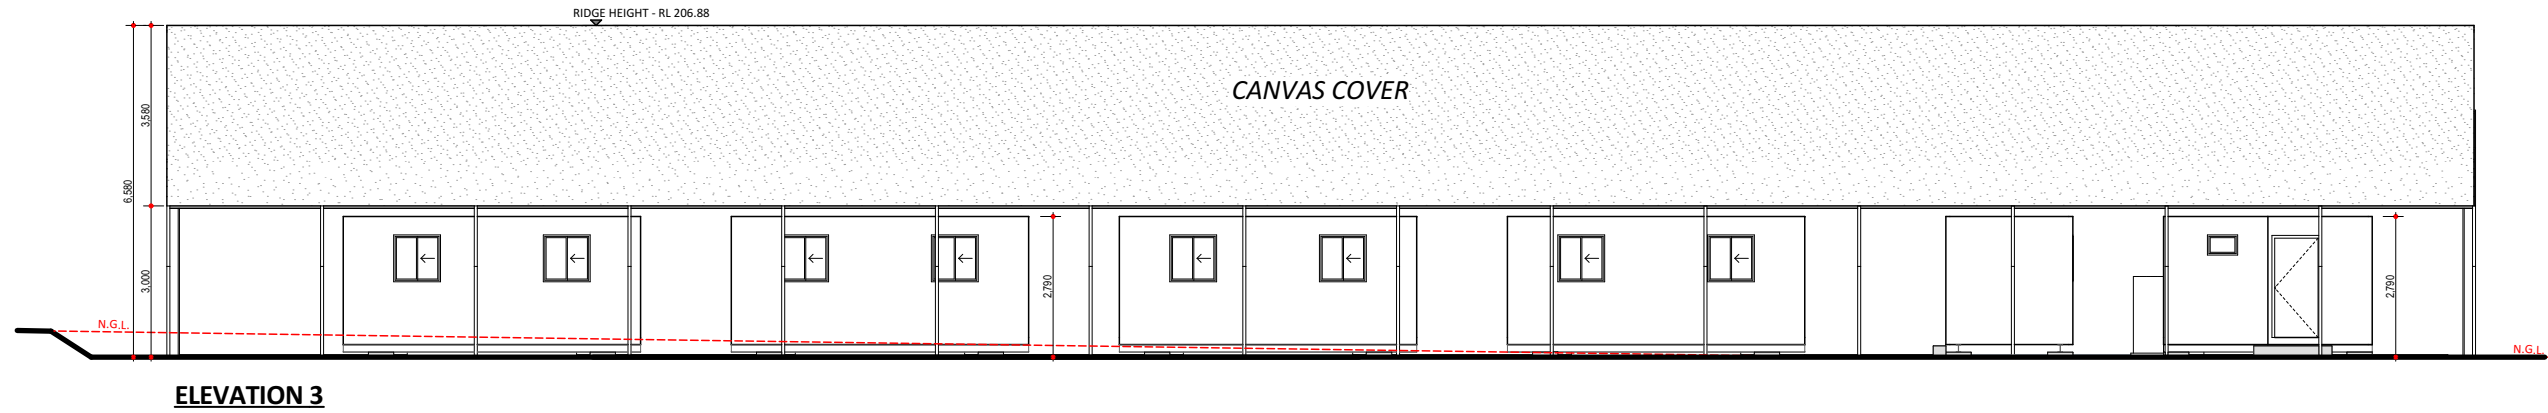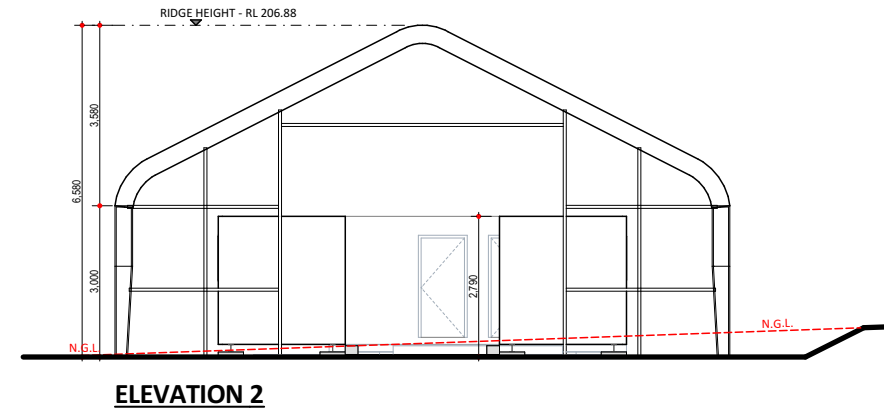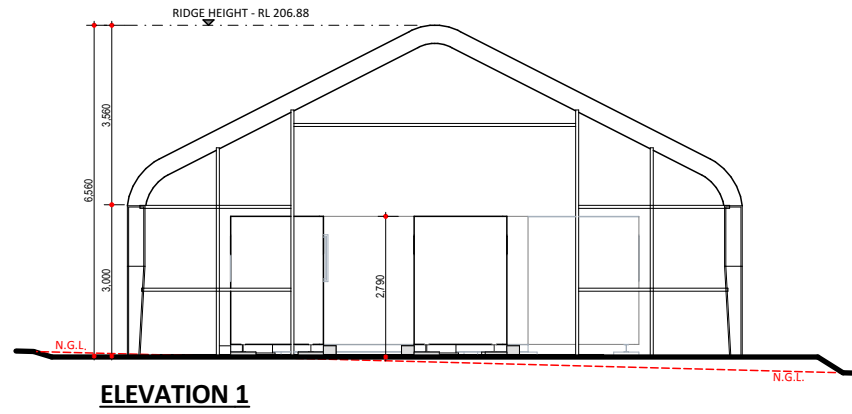

Owner : NEWTON ORCHARDS

Address: #22 STARKIES ROAD, MANJIMUP

 
Drawing ELEVATIONS 1
Title:




Fastlane
Design & Drafting

Mob: 0423 473 057
Email: fastlane.drafting@gmail.com

Date: 02/02/26 Scale: 1:150
Designed: TL
Checked: TL
Local Authority: Shire of Manjimup Sheet 5 Of 9
Plan/Diagram Number: .
CT Number: .
Revision: V1 ORIGINAL:A3

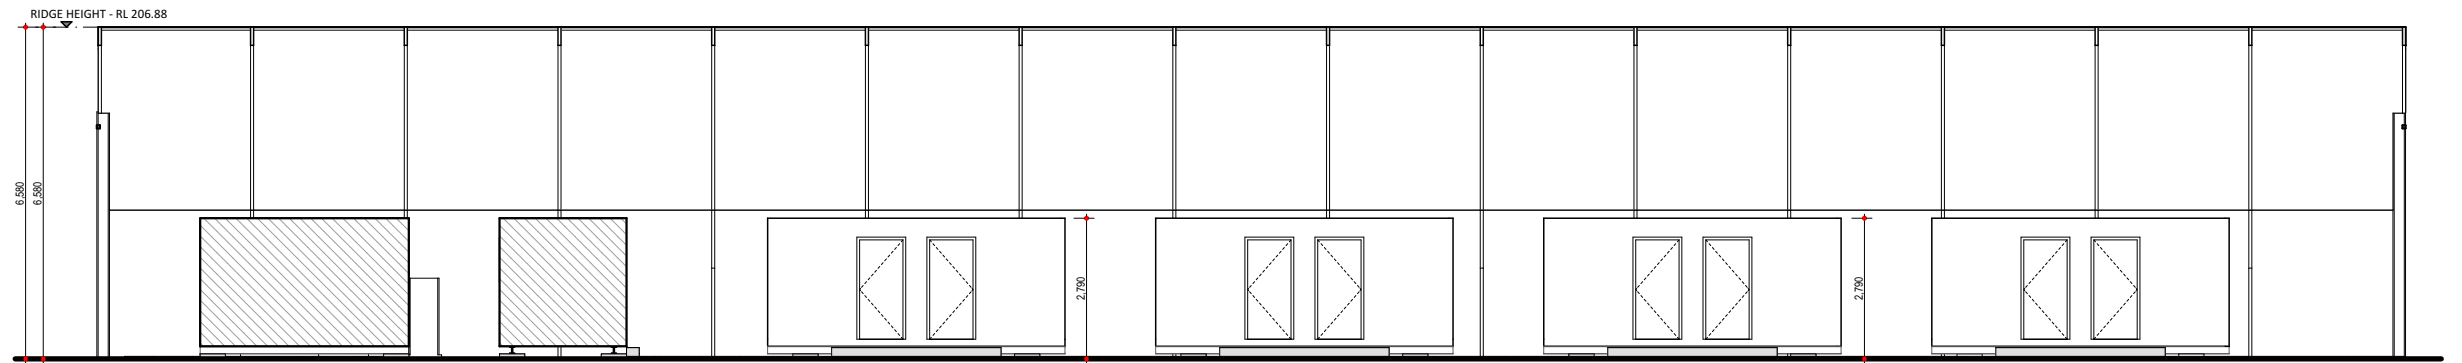

ELEVATION 5

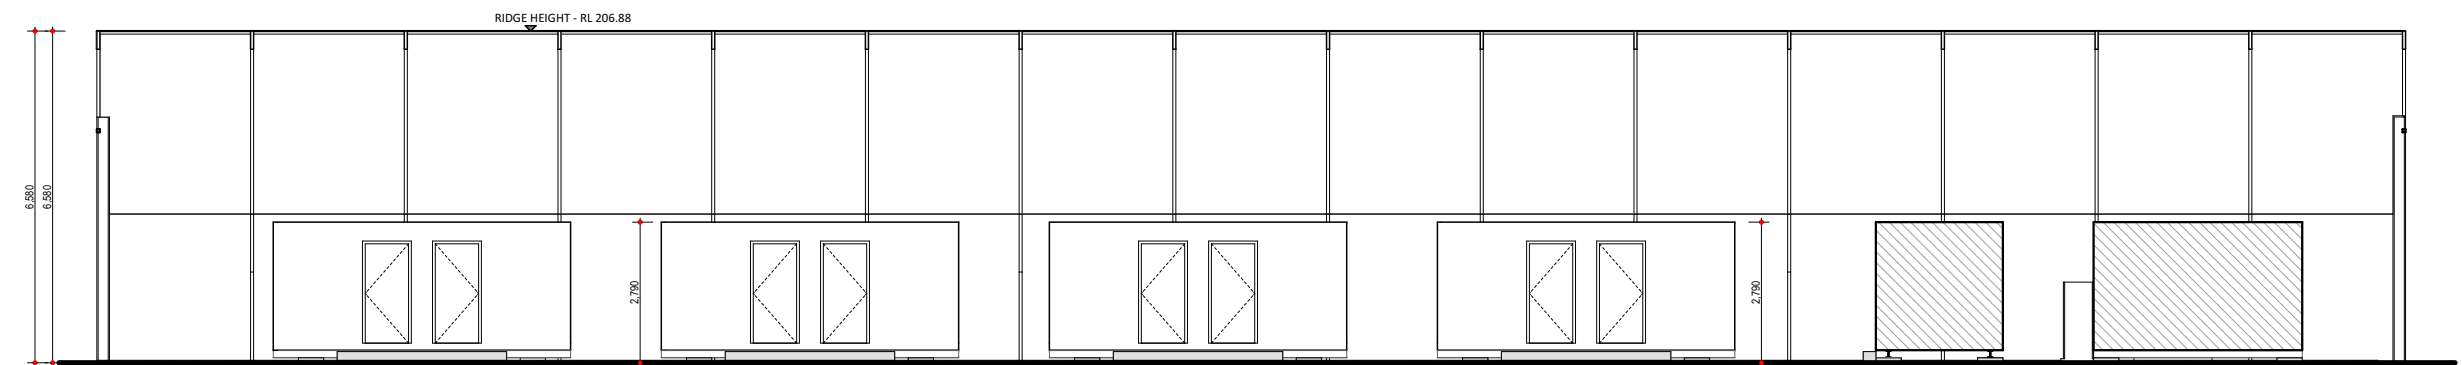


ELEVATION 6

Owner : NEWTON ORCHARDS

Address: #22 STARKIES ROAD, MANJIMUP

Drawing ELEVATIONS 2

 Title:





Fastlane
Design & Drafting

Mob: 0423 473 057
Email: fastlane.drafting@gmail.com

Date: 02/02/26 Scale: 1:100

Designed: TL

Checked: TL

Local Authority: Shire of Manjimup Sheet 6 Of 9

Plan/Diagram Number: .

CT Number: .

Revision: V1 ORIGINAL:A3